
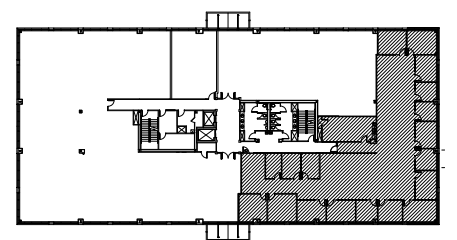


NOT FOR CONSTRUCTION
[CONTRACTOR TO FIELD VERIFY EXISTING
CONDITIONS PRIOR TO PRICING THIS PLAN]

PLAN LEGEND

- EXISTING TO REMAIN
- WALL
 - PARTIAL HEIGHT WALL
 - WINDOW / SIDELIGHT
 - DOOR AND FRAME
- NEW / RELOCATED
- WALL
 - PARTIAL HEIGHT WALL
 - WINDOW / SIDELIGHT
 - BUILT-IN CASEWORK/
PLUMBING FIXTURE
 - DOOR AND FRAME
 - R = RELOCATED FROM
DECONSTRUCTION, PAINTED
 - N = NEW TO MATCH EXISTING
 - G = FRAMELESS GLASS SYSTEM

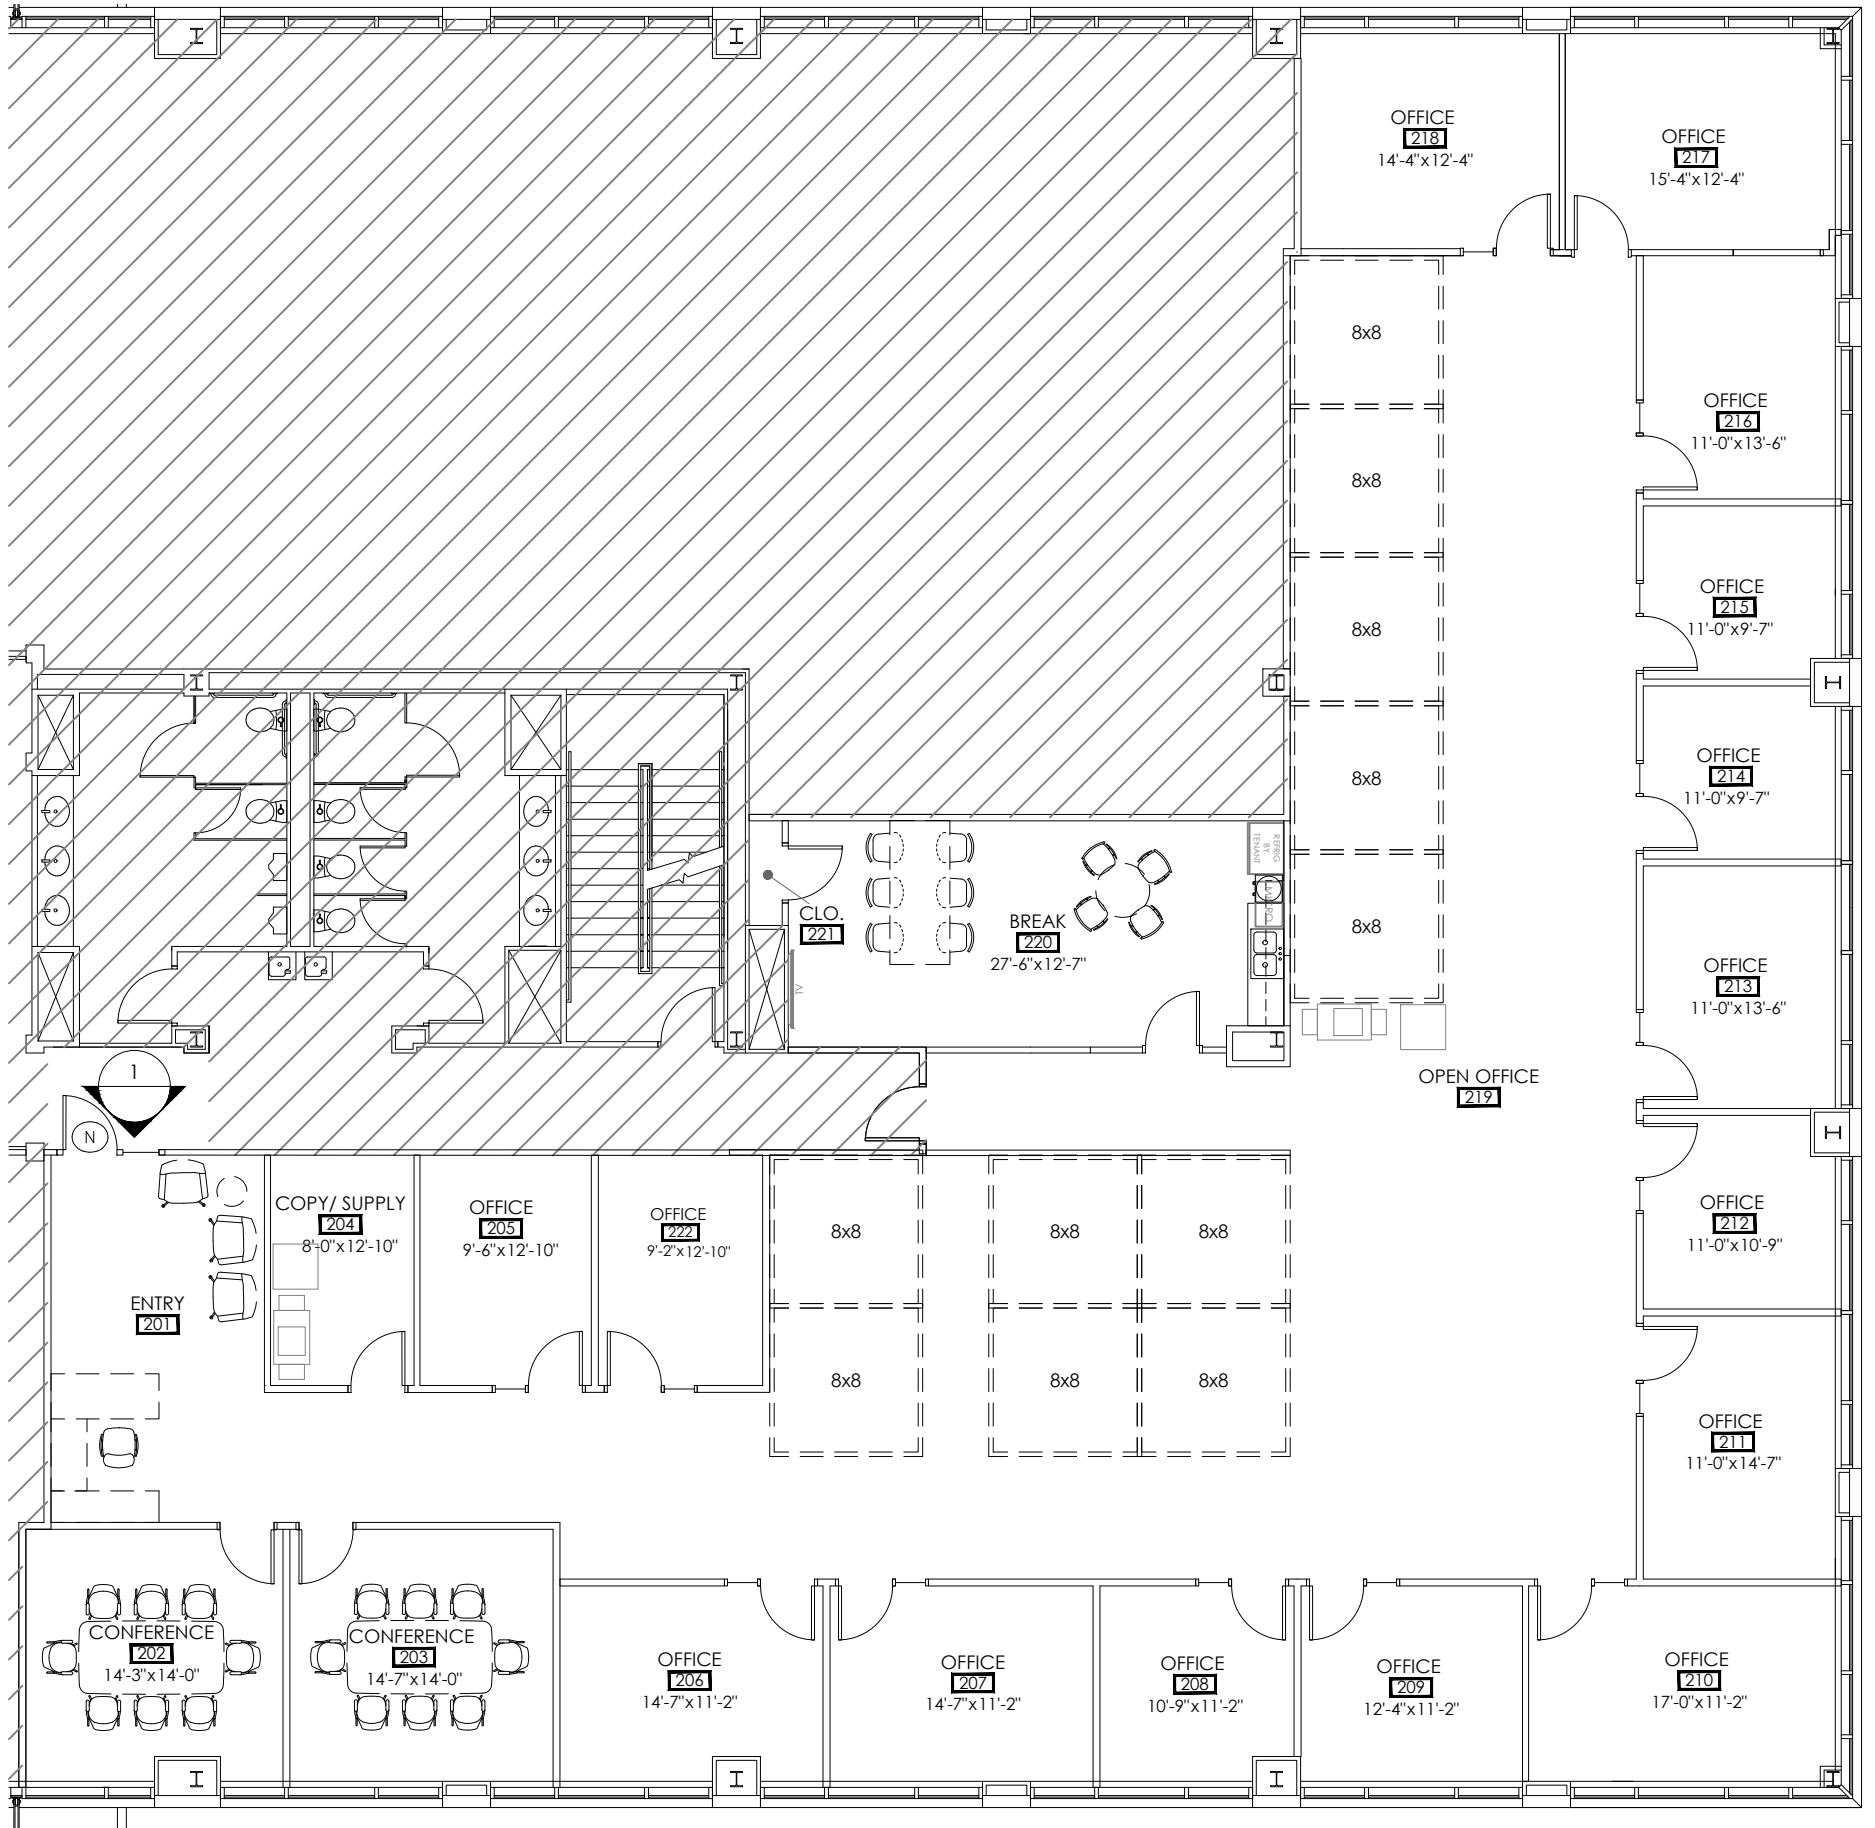

SPEC SUITE

8365 KEYSTONE CROSSING | SUITE 203 | INDIANAPOLIS, IN 46240



2024.405 DATE: 11.08.24 PROJECT MGR: MS SCALE: 3/32" = 1'-0"